

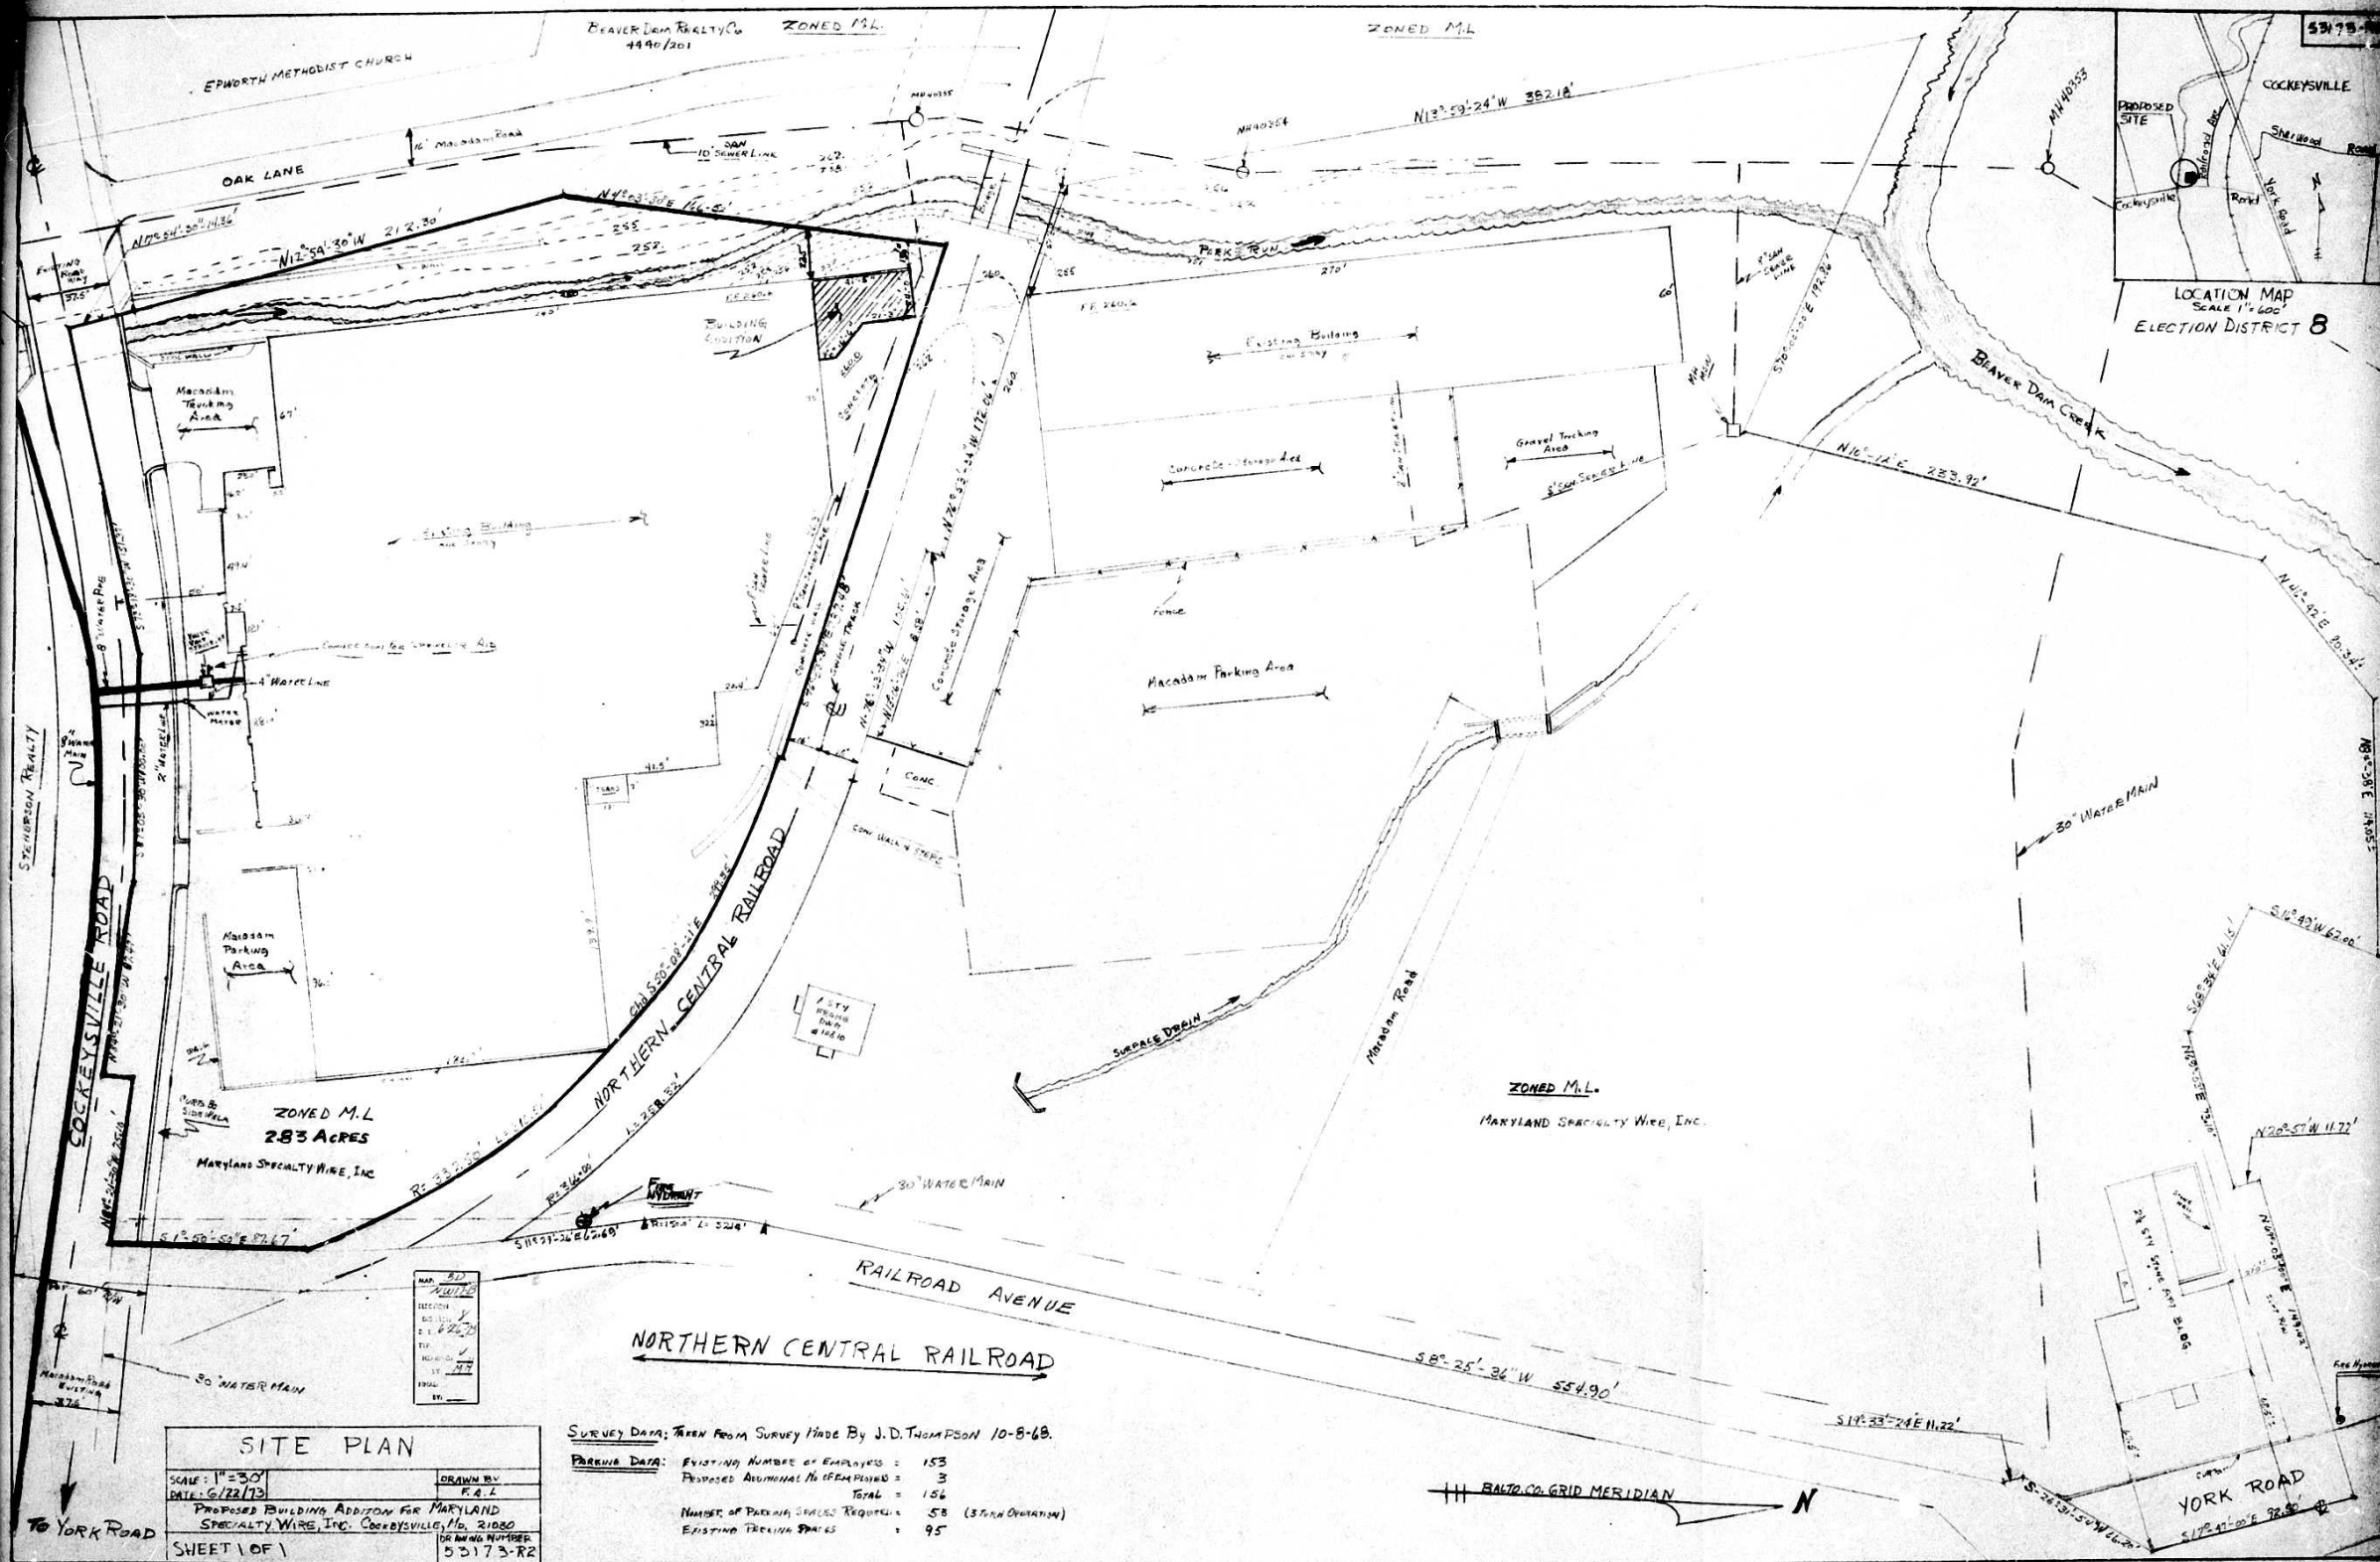


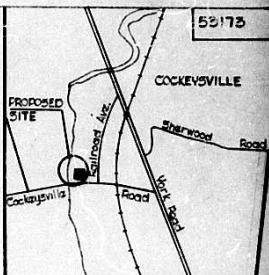

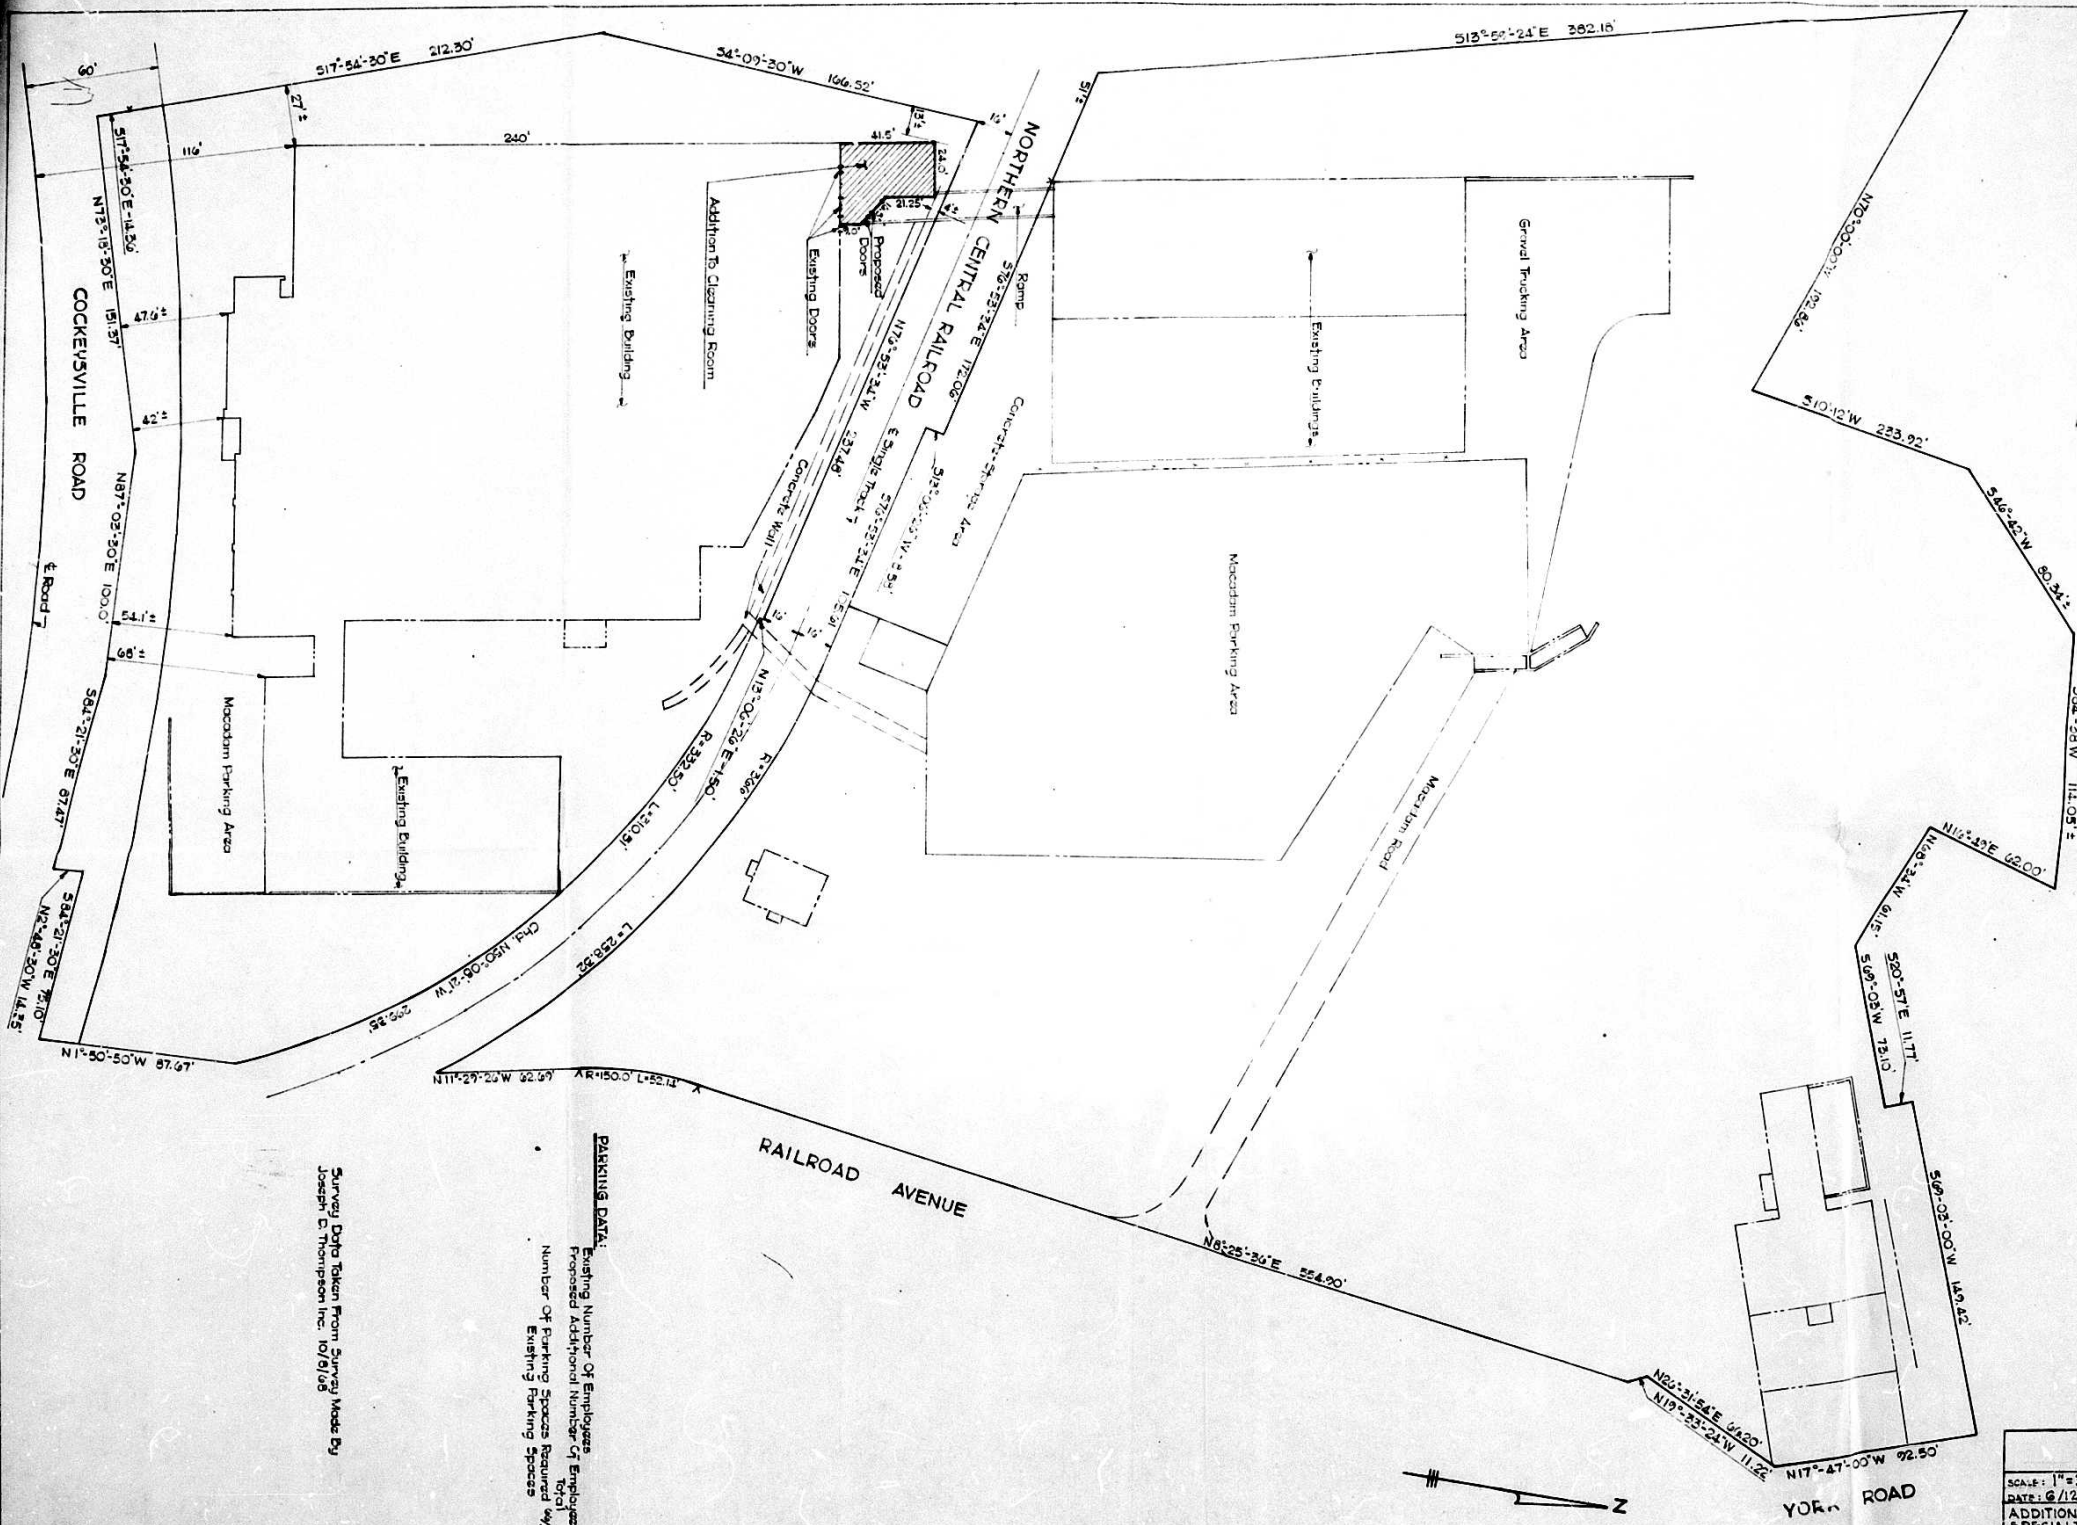



PLANS APPROVED
OFFICE OF PLANNING & ZONING
BY *John Z. Winkler*
DATE 8-22-73
74-27-A

KENNEDY ENGINEERING INC.
CONSULTING ENGINEERS
BEL AIR, MARYLAND

SITE PLAN

SCALE: 1"=50'	APPROVED BY: <i>W.W.M.</i>
DATE: 6/12/73	
ADDITION TO CLEANING BLDG AT MARYLAND SPECIALTY WIRE, COCKEYSVILLE, MD	
SHEET 1 OF 1	DRAWING NUMBER 53173

MICROFILMED

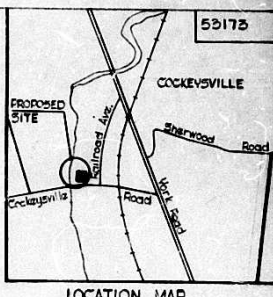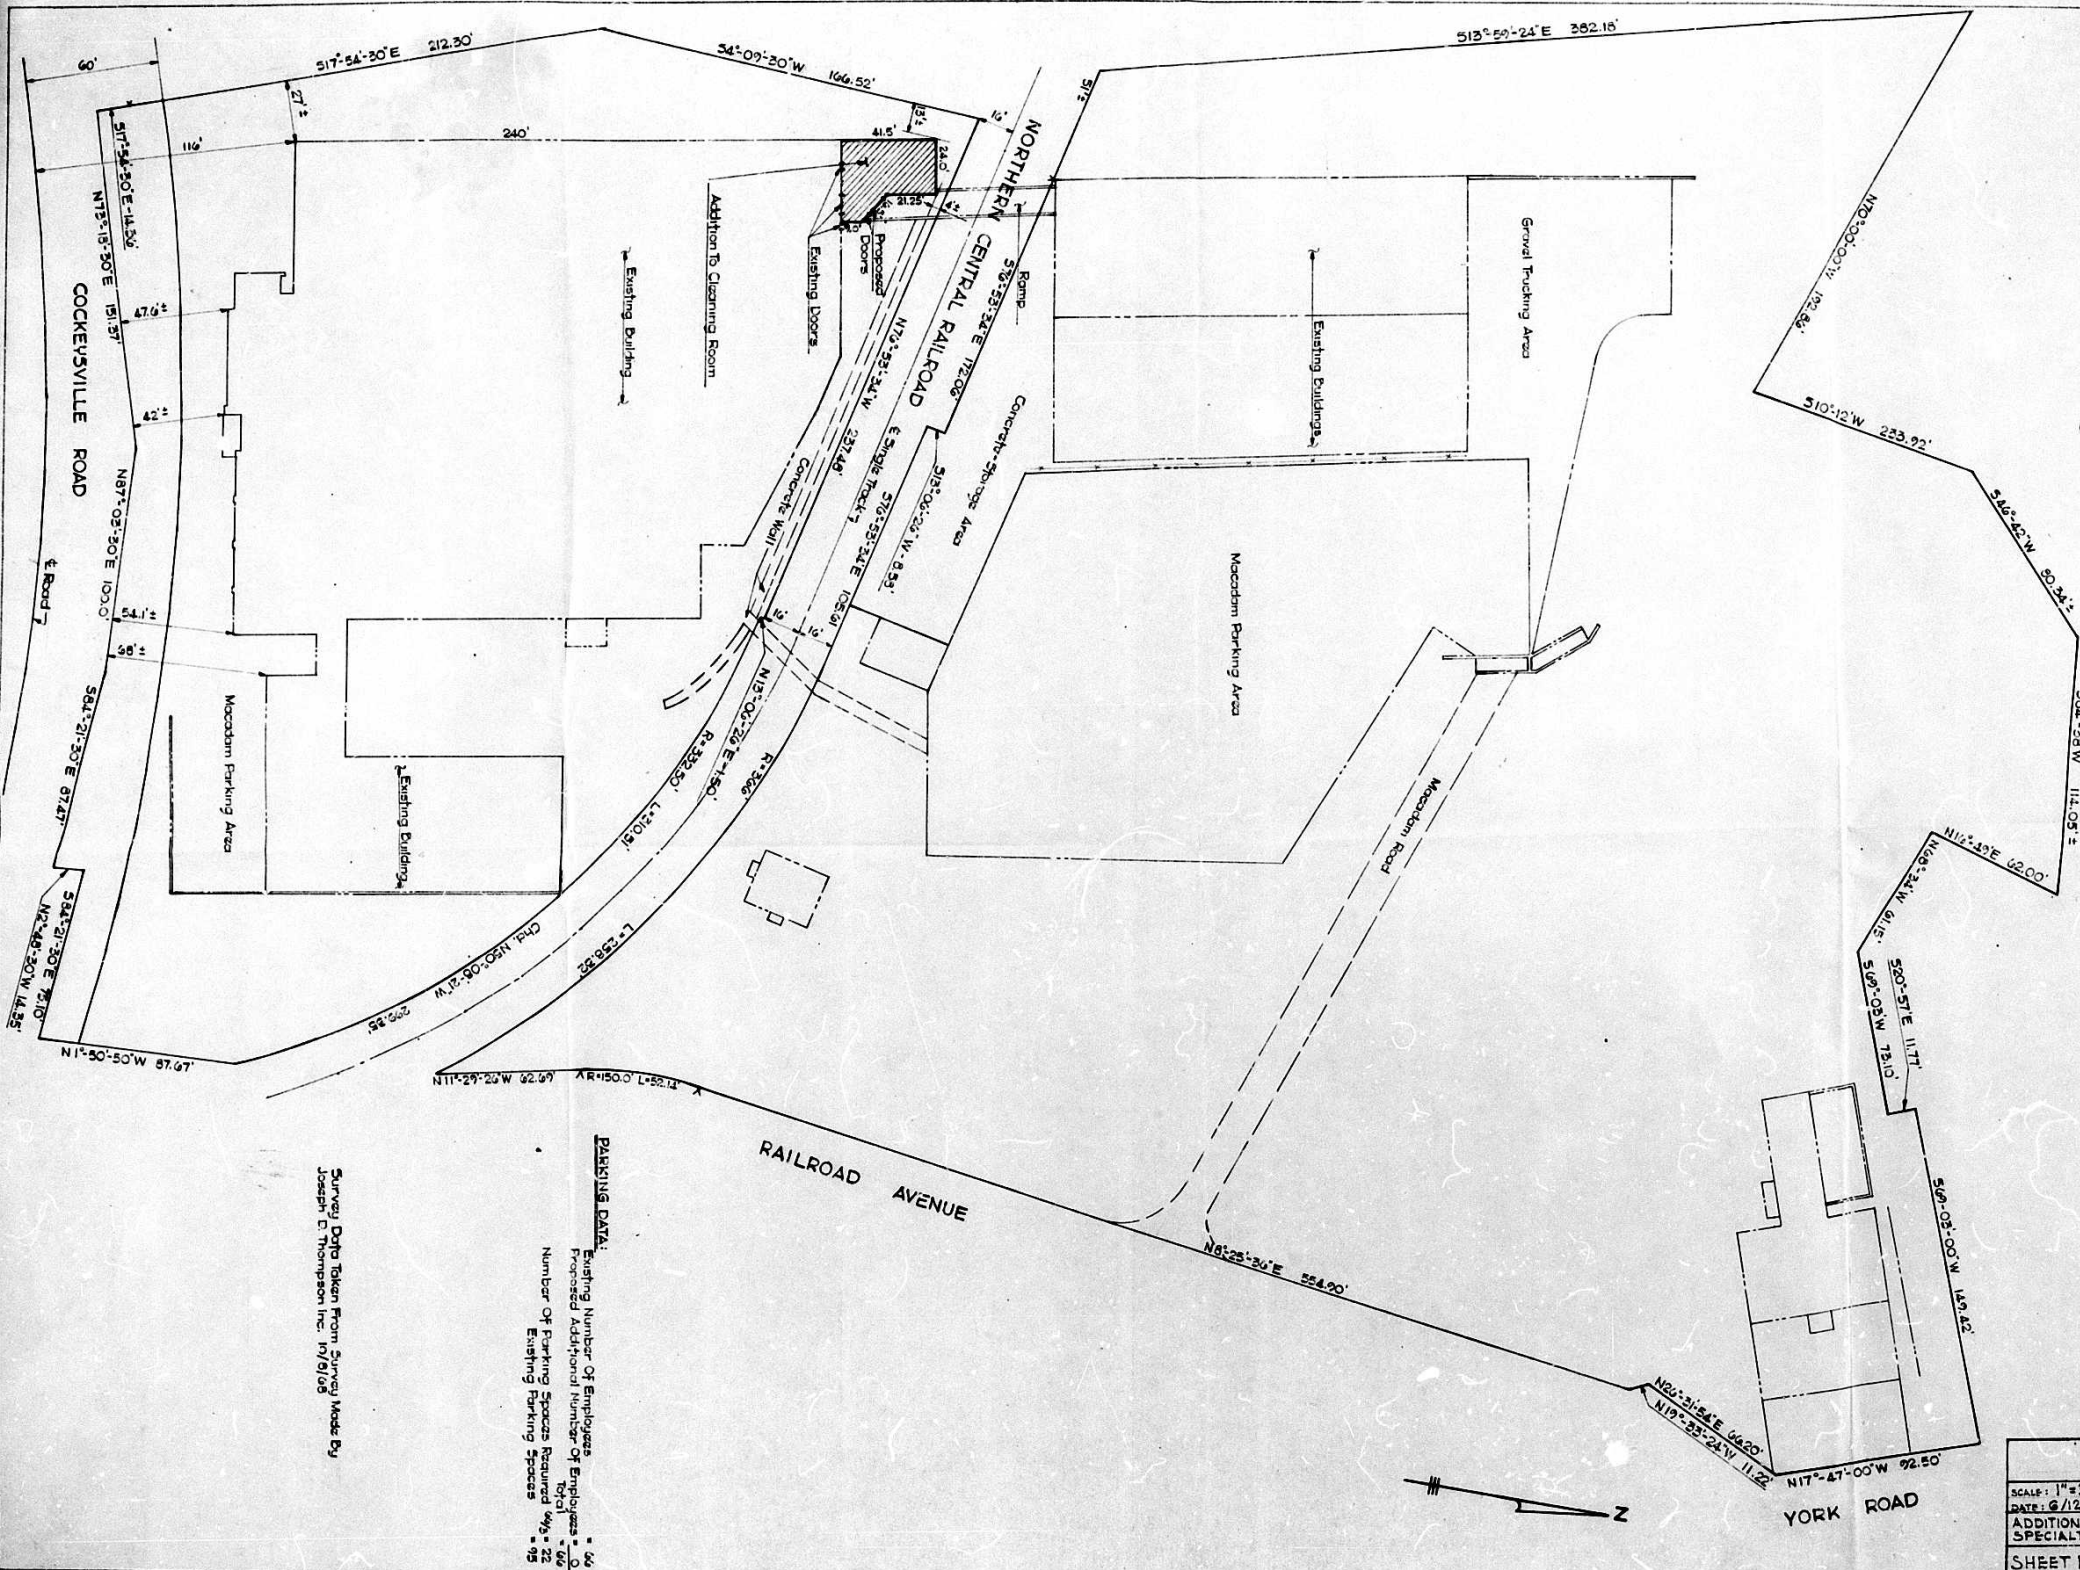

PLANS APPROVED
 OFFICE OF PLANNING & ZONING
 BY: *John D. Thompson*
 DATE: 8-28-73
 74-27-A



KENNEDY ENGINEERING INC.
 CONSULTING ENGINEERS
 BEL AIR, MARYLAND

SITE PLAN	
SCALE: 1" = 50'	APPROVED BY: W.W.M.
DATE: 6/12/73	
ADDITION TO CLEANING BLDG AT MARYLAND SPECIALTY WIRE, COCKEYSVILLE, M.D.	
SHEET 1 OF 1	DRAWING NUMBER: 53173

PARKING DATA:
 Existing Number of Employees: 46
 Proposed Additional Number of Employees: 40
 Number of Parking Spaces Required: 86
 Existing Parking Spaces: 95

Survey Data Taken From Survey Made By
 Joseph D. Thompson Inc. 10/9/68

